


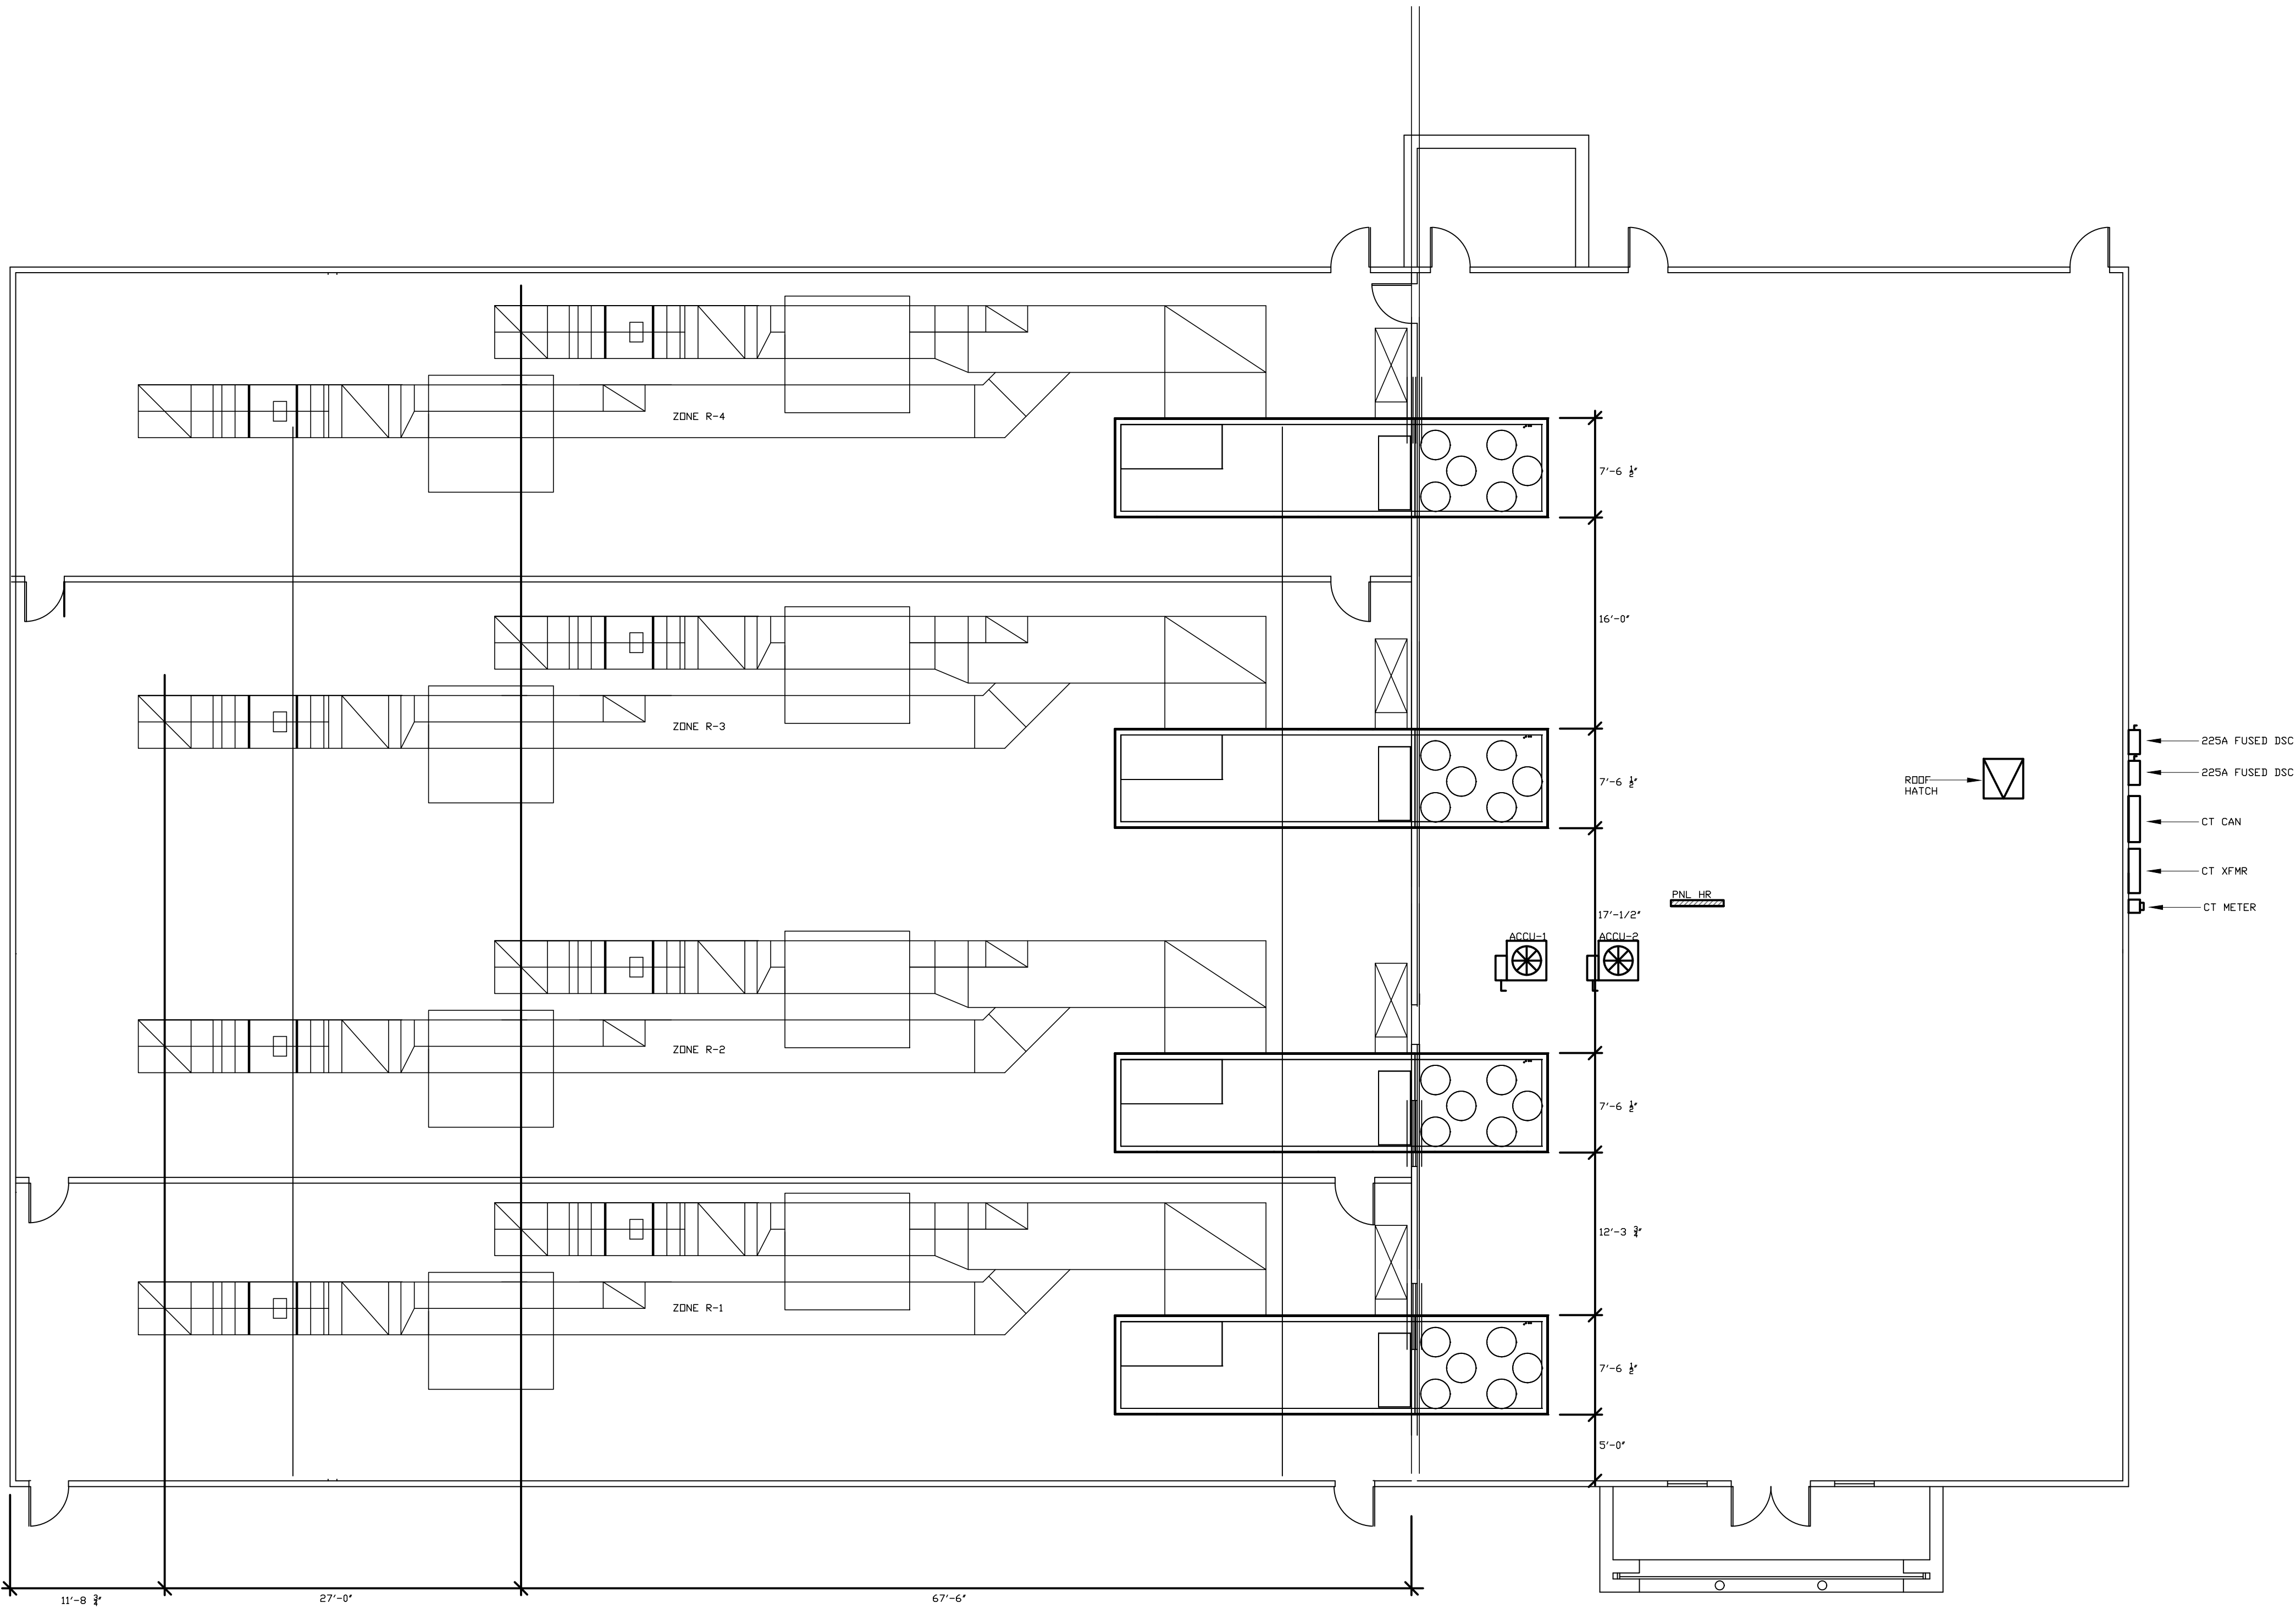

MECHANICAL ROOF PLAN

SCALE: 1/8"=1'-0"

| No. | Date | Revisions | App. |
|-----|------|-----------|------|
|     |      |           | RAS  |


MECHANICAL ROOF PLAN

SPRING FAMILY GUN RANGE

ENGINEERING BY:  
QUEST ENGINEERING  
304 North Main Street #1  
Conroe, Texas 77301  
Phone: (713) 252-3729  
rsaikowski@consolidated.net  
© Ronald A Saikowski PE LEEP AP 2017  
TEXAS REGISTRATION NO. FOR ENGINEERING FIRM IS F-10574



I, RON A. SAIKOWSKI,  
P.E., AUTHORIZED THE  
PLACEMENT OF THIS  
SEAL ON THIS  
DRAWING FOR THE  
PURPOSE OF ISSUING  
THIS DOCUMENT  
AS SPECIFIED BELOW

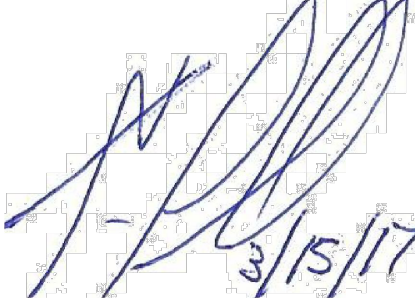

3/15/17

|                                     |                          |
|-------------------------------------|--------------------------|
| <input type="checkbox"/>            | Not For Construction     |
| <input type="checkbox"/>            | For Background Use Only  |
| <input type="checkbox"/>            | Preliminary              |
| <input type="checkbox"/>            | For Concept Approval     |
| <input type="checkbox"/>            | Preliminary Bid Set      |
| <input type="checkbox"/>            | For Preliminary Approval |
| <input type="checkbox"/>            | Check Set                |
| <input type="checkbox"/>            | Permit                   |
| <input checked="" type="checkbox"/> | For Final Approval       |
| <input type="checkbox"/>            | For Construction         |

NOTE:  
CONSTRUCTION SHALL NOT PROCEED UNTIL  
CONTRACTOR HAS OBTAINED ALL PERMITS AND  
INCORPORATED COMMENTS FROM TEXAS  
ACCESSIBILITY STANDARDS REVIEW AND PERMITTING  
ENTITIES IN WORK.

SHEET NO.

M-5