


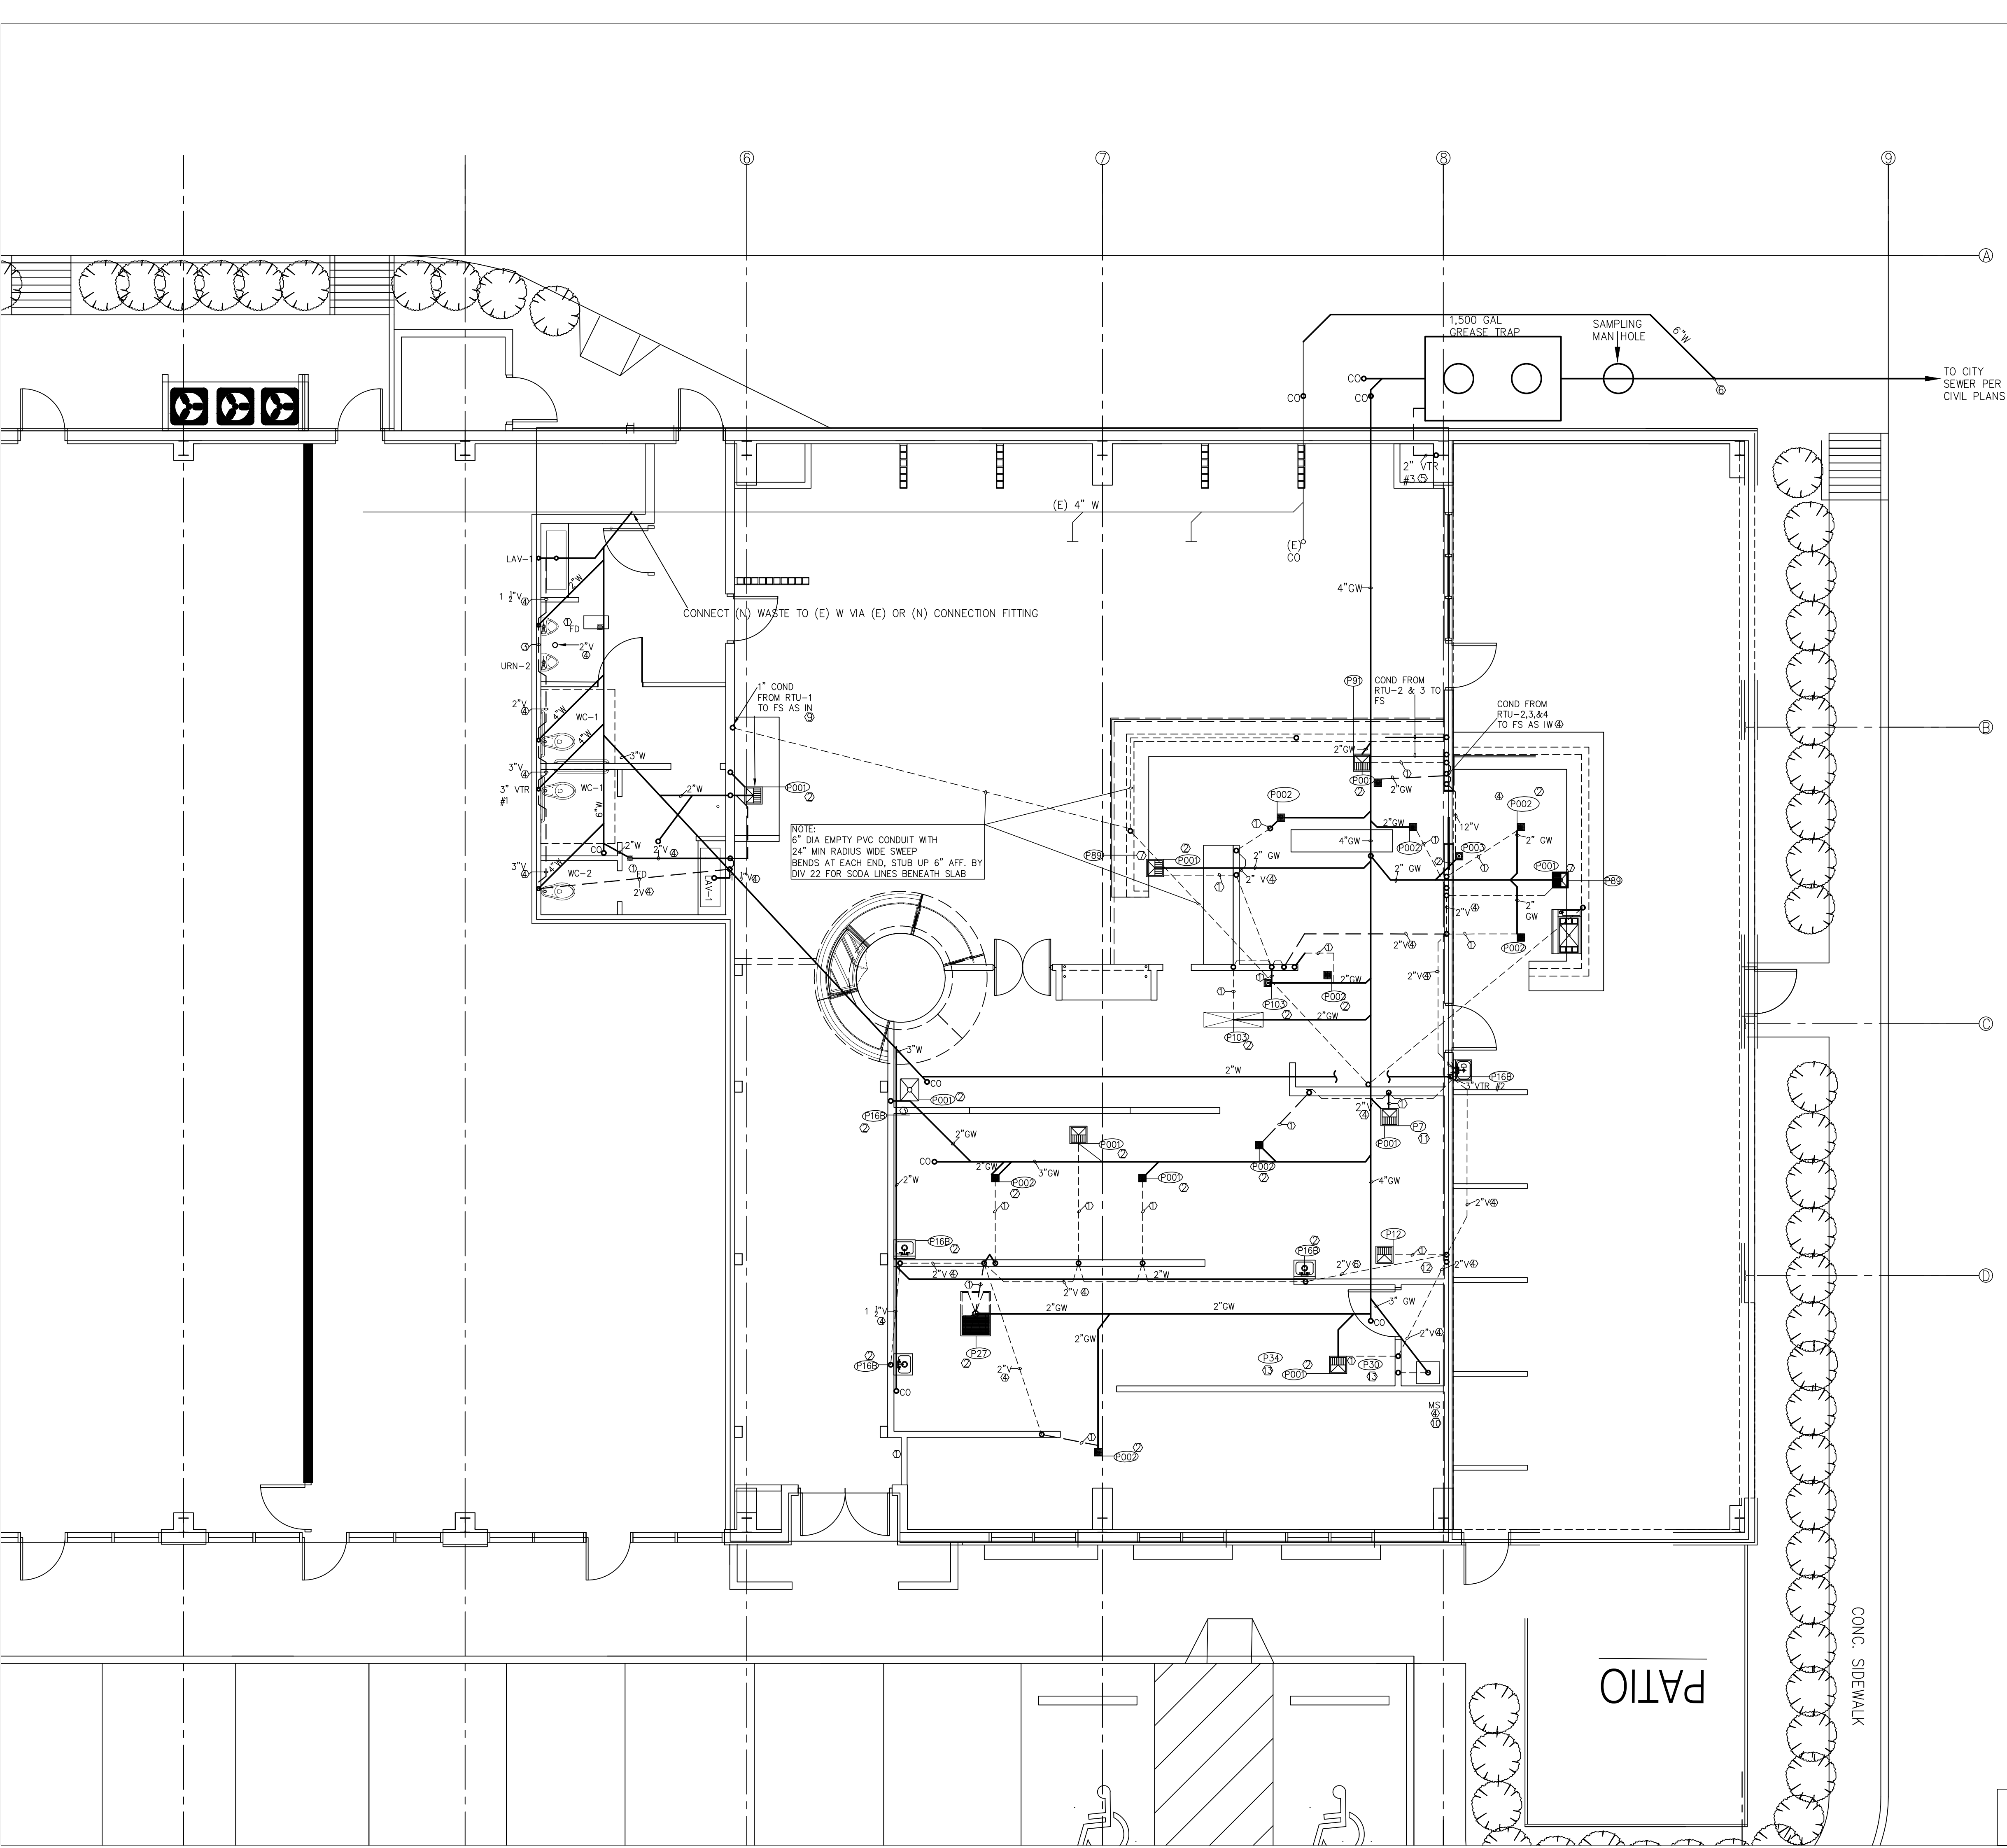

KEYED NOTES - WASTEWATER

MARK	DESCRIPTION
1	INSTALL TWO-INCH VENT FROM FLOOR DRAIN ABOVE FLOOD LINE OF P-TRAP BELOW FLOOR TO NEARBY WALL, THEN UP INSIDE WALL TO ABOVE 42 INCHES ABOVE FINISH FLOOR TO CONNECT TO OTHER VENTS. EXTEND VENT PIPE CONCEALED WITHIN WALL TO ABOVE CEILING AND FIELD ROUTE PER KEYED NOTE 4 TO VENT THROUGH ROOF (VTR). ROUTE 1/2-INCH WATER LINE FROM P-TRAP PRIMER PORT BELOW SLAB ALONG VENT LINE AND UP INSIDE WALL TO NEW TRAP PRIMER LOCATED ON WATER PLUMBING PLAN ABOVE CEILING. PROTECT PLUMBING LINES WITHIN WALLS WITH 12 GAGE STEEL PLATES AT STUDS AND PLATES.
2	CONNECT VENT AND WASTE LINES TO PLUMBING FIXTURES PER SPECIFIED SIZES IN PLUMBING FIXTURE CONNECTION SCHEDULE. SUPPORT LINES WITHIN WALLS AND PROTECT FROM GYPBOARD/EXTERIOR WALL FASTENERS. SUPPORT PIPES WITHIN WALLS AT MAXIMUM SPACING OF SIX FEET. PROVIDE WALL SUPPORTS WITHIN WALLS AS REQUIRED FOR PLUMBING FIXTURE SUPPORTS. DO NOT CUT THROUGH WALL SUPPORTS TO THE EXTENT THAT WALLS ARE STRUCTURALLY UNSOUND.
3	ROUTE NEW WASTE LINE IN MID-POINT OF WALL BETWEEN PLUMBING FIXTURES, THEN DOWN BELOW FLOOR TO CONNECT TO WASTE LINE BELOW SLAB VIA WYE FITTING. PROTECT WASTE LINE AT EACH STUD AND PLATE WITH 12 GAGE PLATES.
4	ROUTE VENT LINE ABOVE CEILING SUPPORTED FROM ROOF PURLINS AT MAXIMUM SPACING OF 6-FEET. COORDINATE EXACT LOCATION OF VENTS ABOVE CEILING WITH OTHER TRADES WITH DUCTS, HOODS, AND LIGHT FIXTURES HAVING PRIORITY AS TO LOCATION.
5	ROUTE TWO-INCH VENT FROM NEW 1,500 GALLON GREASE TRAP UNDER GROUND AND FOUNDATION TO CHASE FOR COLUMN AND THEN UP INSIDE CHASE THROUGH ROOF FOR VENT THROUGH ROOF (VTR). PROVIDE
6	CONNECT NEW WASTE LINE TO EXISTING WASTE LINE PER FITTING. COORDINATE HORIZONTAL AND VERTICAL LOCATION OF EXISTING WASTE LINE PRIOR TO CONNECTION TO ESTABLISH LINE DEPTHS AND SLOPES.

JLE

Remarks

Primary & Secondary
Provide Stainless Steel Cover for Exposed Exterior Pipe
Use Rubber-tight Boot for roof penetration
Within 10' of cooking Equipment/Hood
Grease Waste Temperature < 110 F
Grease Waste Temperature > 110 F

PROJECT INFORMATION:

TOMMY BUI
KINGS BIERHAUS
828 W. FM 649
DICKINSON, TEXAS
SUITE 100

MARISOL GRETSCH
DESIGNER CONSULTANT
281-844-1845
marisolgretsch@hotmail.com

ENGINEERING BY:

QUEST ENGINEERING

304 North Main Street #1
Conroe, Texas 77301
Phone: (713) 252-3729
rsaikowski@consolidated.net
© Ronald A Saikowski PE LEEP AP 2017
TEXAS REGISTRATION NO. FOR ENGINEERING FIRM IS F-10574



I, RON A. SAIKOWSKI,
P.E., AUTHORIZED THE
PLACEMENT OF THIS
SEAL ON THIS
DRAWING FOR THE
PURPOSE OF ISSUING
THIS DOCUMENT
AS SPECIFIED BELOW

☐ Not For Construction
☐ For Background Use Only
☐ Preliminary
☐ For Concept Approval
☐ Preliminary Bid Set
☐ For Preliminary Approval
☐ Check Set
☒ Permit
☒ For Final Approval
☒ For Construction

NOTE:
CONTRACTOR SHALL NOT PROCEED UNTIL
CONTRACTOR HAS OBTAINED ALL PERMITS AND
INCORPORATED COMMENTS FROM TEXAS
ACCESSIBILITY STANDARDS REVIEW AND PERMITTING
ENTITIES IN WORK.

DATE
1/10/17

PROJECT NUMBER
1607

SCALE
3/16"=1'

DRAWING NAME
WASTE PLUMBING PLAN

DRAWING NAME
P-1.1

SEE SHT P-3.1 FOR & SHEET P-3.2
FOR SCHEDULES & DETAILS